


# Proposed Residential Development at Main Street, Ballincollig, Cork Planning Drawings

6483-0000	Drawing Index & Locality Plan
6483-0020	Proposed Drainage Layout
6483-0022	Proposed SudS Layout
6483-0023	Proposed SudS Section Details
6483-0025	Proposed Waste Water Details (Sheet 1 of 2)
6483-0026	Proposed Waste Water Details (Sheet 2 of 2)
6483-0030	Proposed Watermain Layout
6483-0035	Proposed Watermain Details (Sheet 1 of 2)
6483-0036	Proposed Watermain Details (Sheet 2 of 2)

### Drawing Index



**Aerial Plan**

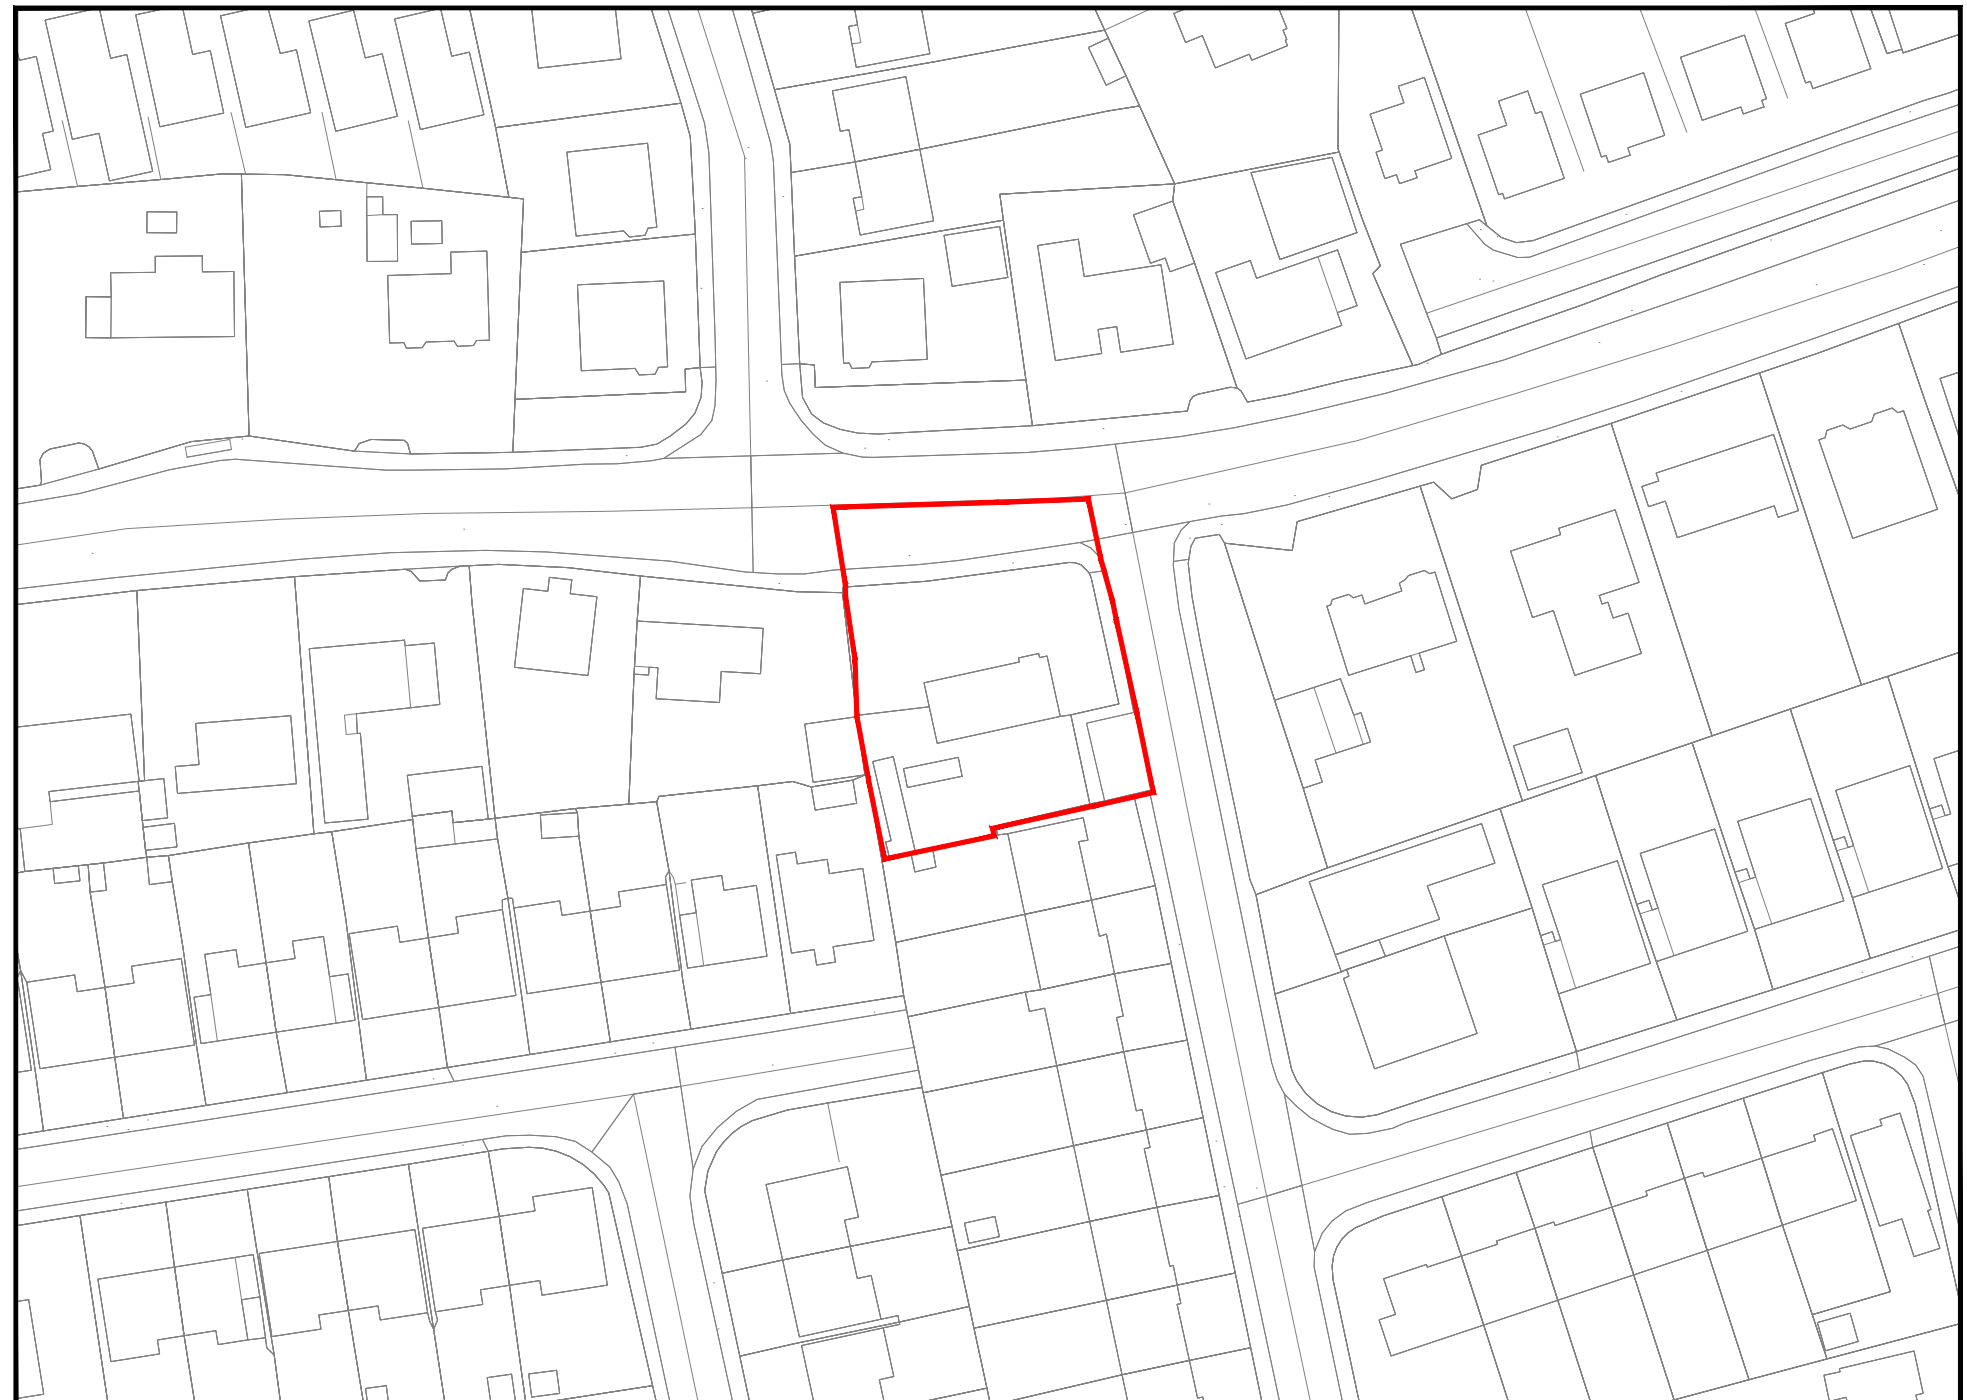

**Locality Plan**



REV.	DRAWN	CHKD	APPRVD	DATE	DETAILS
A	K.M.	S.O'G.	L.O.T.	12.09.24	Issued for Planning

CLIENT	
PROJECT	Residential Development, Main street, Ballincollig, Cork

DRAWING TITLE		Drawing Index & Locality Plan.	
SHEET	SCALE	PROJECT NO.	DRAWING NO.
A3	NTS	6483	0000
STATUS/ISSUE		A	