


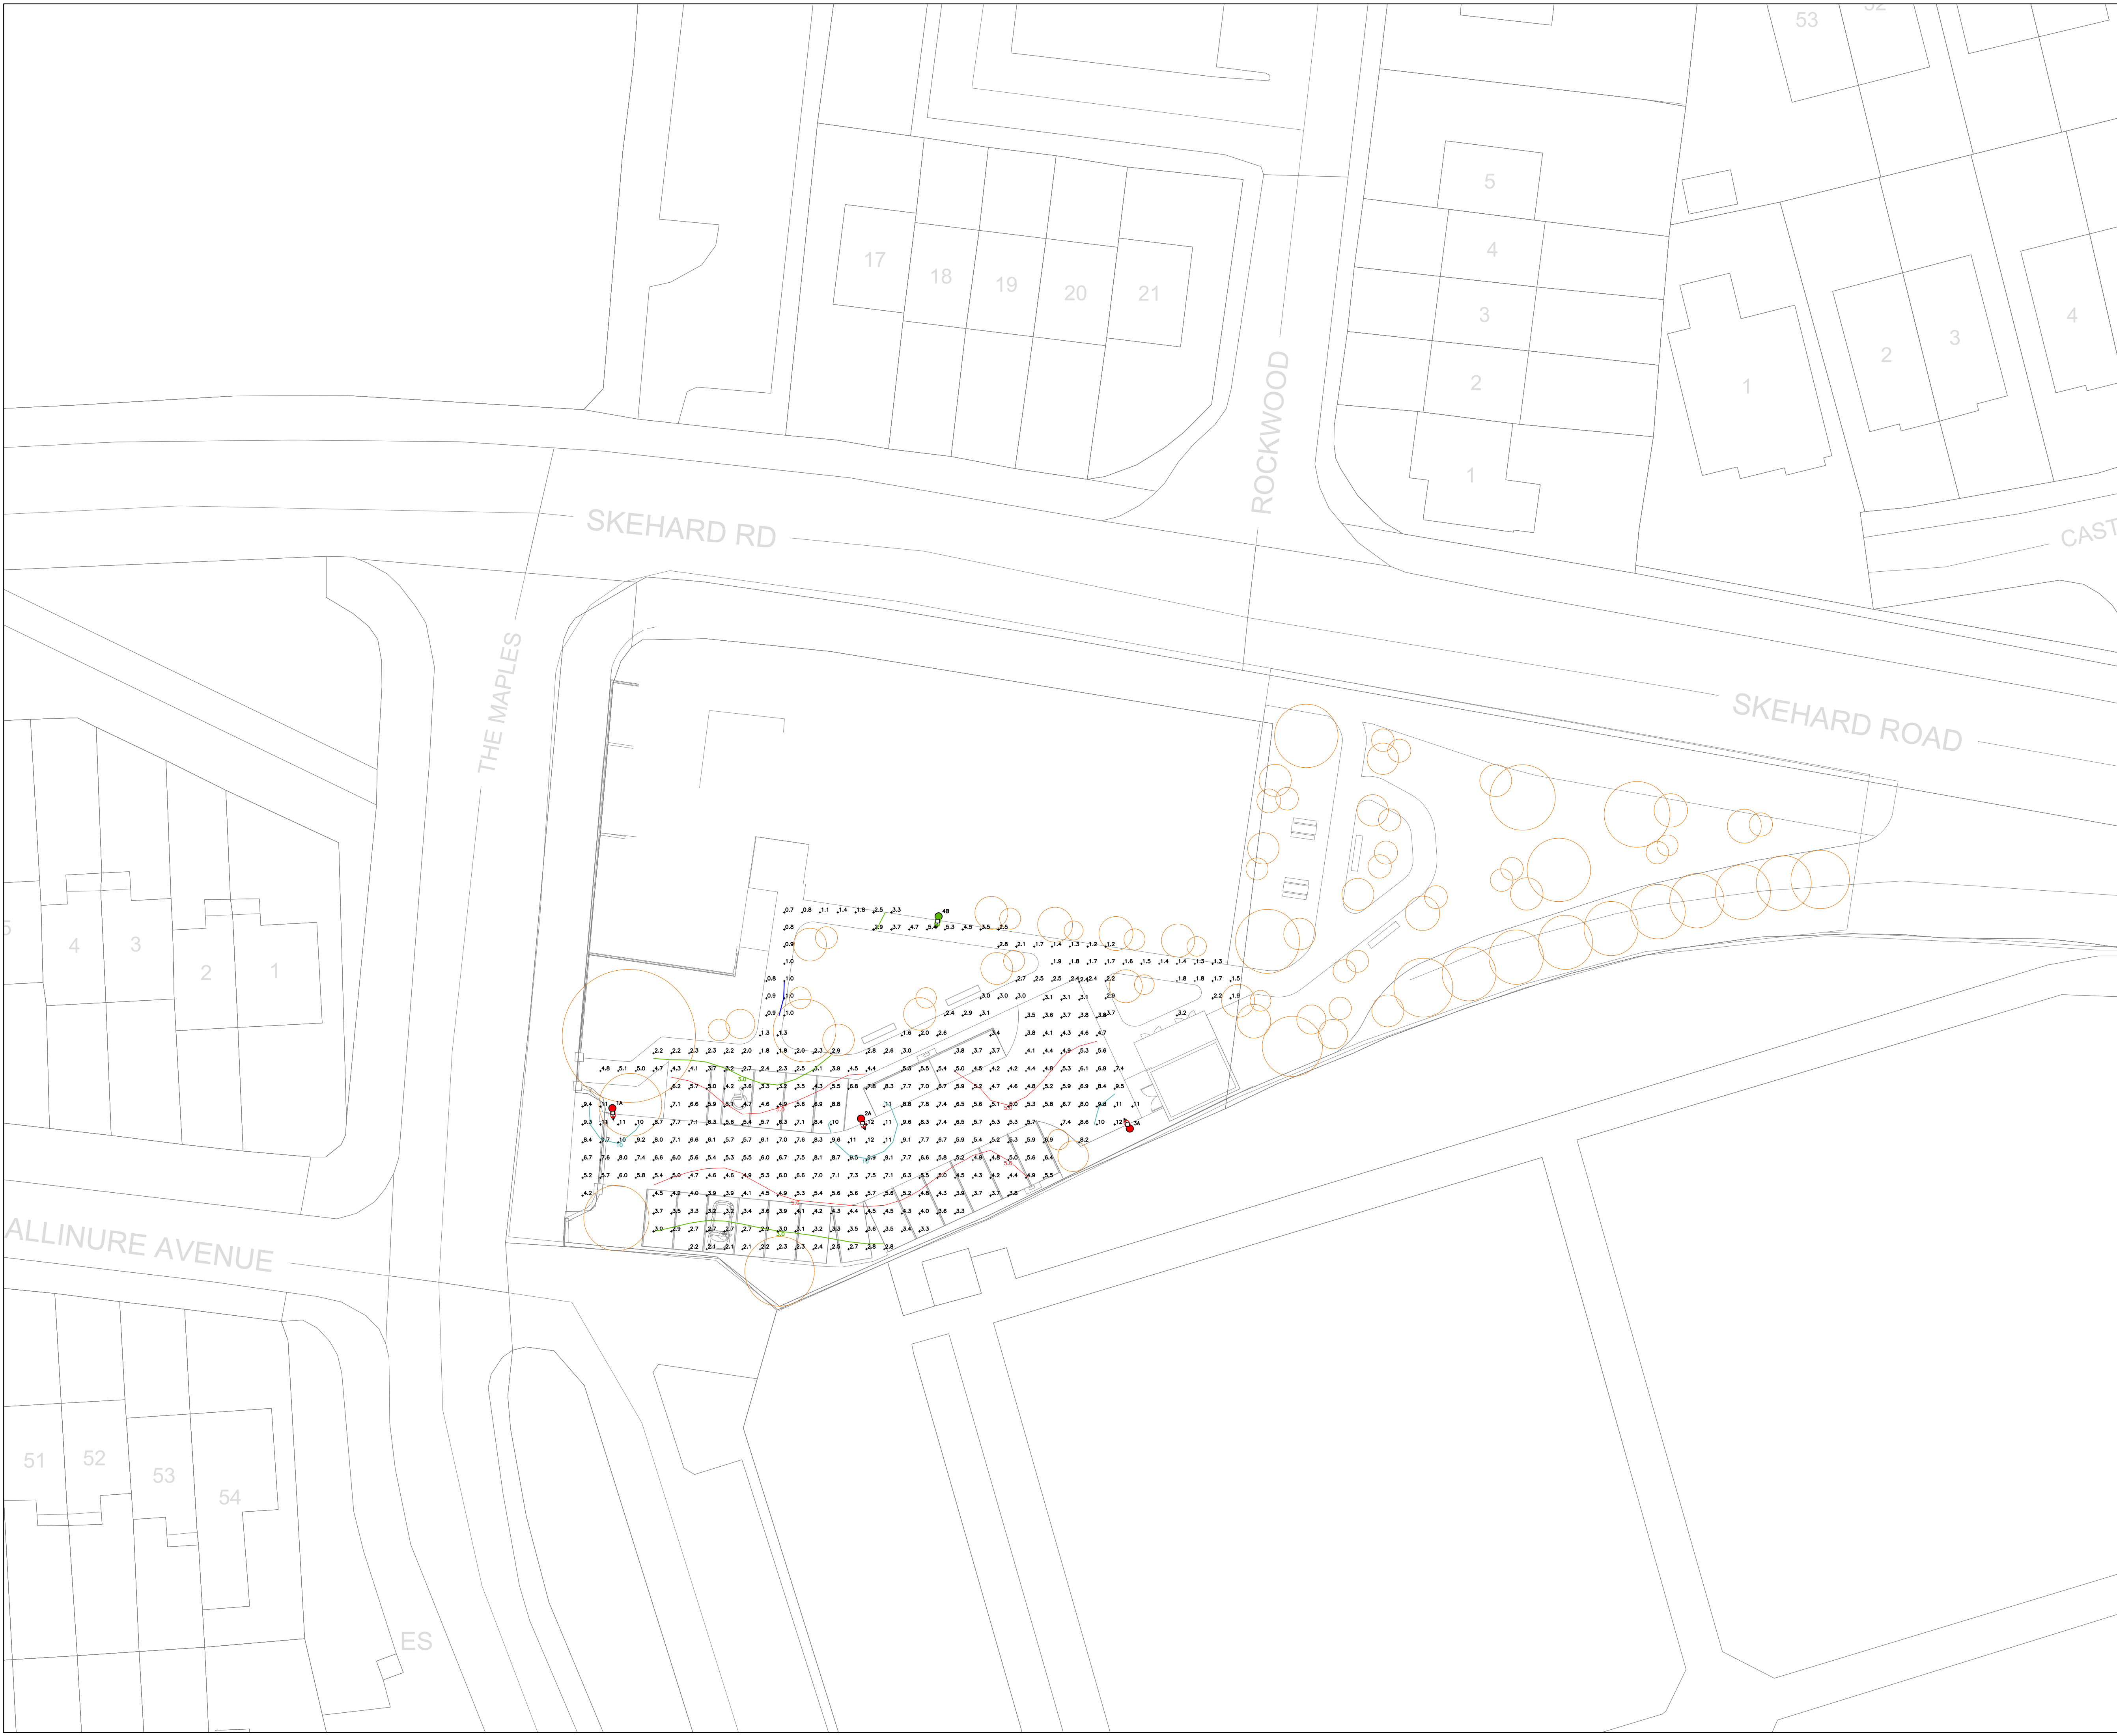

NOTES:

ANY DISCREPANCIES OR OMISSIONS TO BE REPORTED TO ENX IMMEDIATELY.
DO NOT SCALE - WORK FROM FIGURED DIMENSIONS ONLY.
THIS DRAWING TO BE READ IN CONJUNCTION WITH ALL CIVIL ENGINEERS, STRUCTURAL ENGINEERS, ARCHITECTS & ALL OTHER RELEVANT DRAWINGS & SPECIFICATIONS RELATING TO THE PROJECT.
ALL DIMENSIONS TO BE CONFIRMED ON SITE.
THIS DRAWING IS THE PROPERTY OF ENX AND IT OR ITS CONTENTS CANNOT BE COPIED, REPRODUCED OR OTHERWISE USED WITHOUT THE PERMISSION & CONSENT OF ENX. ©

Grid 1
Results – Horizontal Illuminance (lux)
Eav= 5.41
Emin= 1.29
Emax= 12.35
Emin/Emax= 0.10
Emin/Eav= 0.24
Emax/Eav= 2.28

Grid 2
Results – Horizontal Illuminance (lux)
Eav= 2.14
Emin= 0.66
Emax= 5.42
Emin/Emax= 0.12
Emin/Eav= 0.31
Emax/Eav= 2.53

Luminaire Data

Luminaire A BGP702 DM70
Lamp LED–HB 5.2S 740 MF 0.80


Luminaire B BGP701 DM10
Lamp LED–HB 5.2S 740 MF 0.80

Key

- Luminaire A Column
- Luminaire B Column
- Beam Aiming Target
- Photometric Centre

All Dimensions in metres

01	ISSUED FOR REVIEW & COMMENT	06-05-2025
00	ISSUED FOR REVIEW & COMMENT	23-08-2024
REV No.	DESCRIPTION	DATE

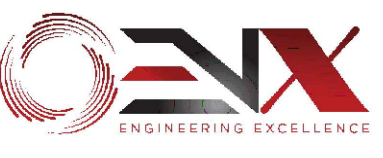

ENGINEERING EXCELLENCE

Mechanical, Electrical & Energy Consultants

Block 5,
High Street,
Dublin 24, D24 YK8N

Phone: +353 1 532 1578
e-mail: info@enx.ie
Web: www.enx.com

PROJECT/CLIENT:

Residential Development at Mahon For Clúid

ARCHITECT:

PLUSARCHITECTURE

DRAWING TITLE:

**SITE SERVICES LAYOUTS
PUBLIC LIGHTING LAYOUT**

<u>DRAWING REFERENCE:</u> 3200[6-J01	<u>DATE:</u> MAY 2025	<u>DRAWN:</u> M.L	<u>SCALE @ A1/A3:</u> 250 / 500
--	---------------------------------	-----------------------------	---